
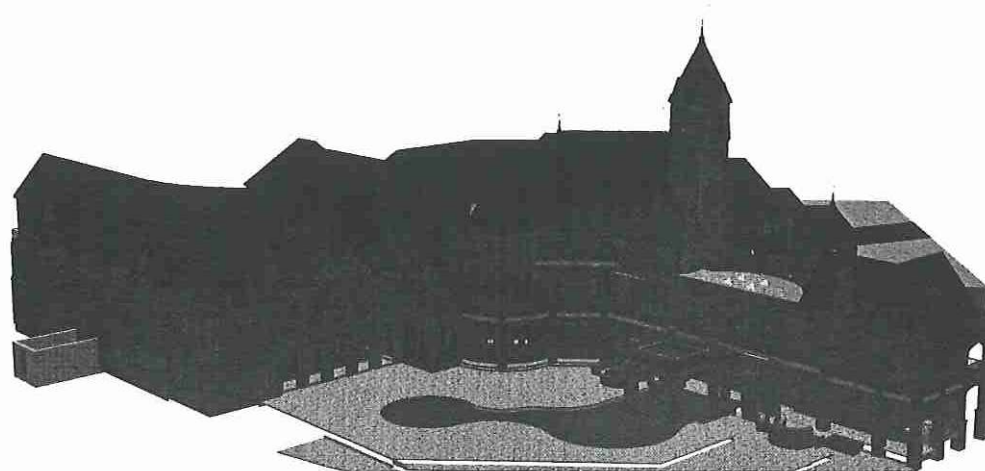


*All numbers are approximate. Buyer and Buyers' agent to due own due diligence.

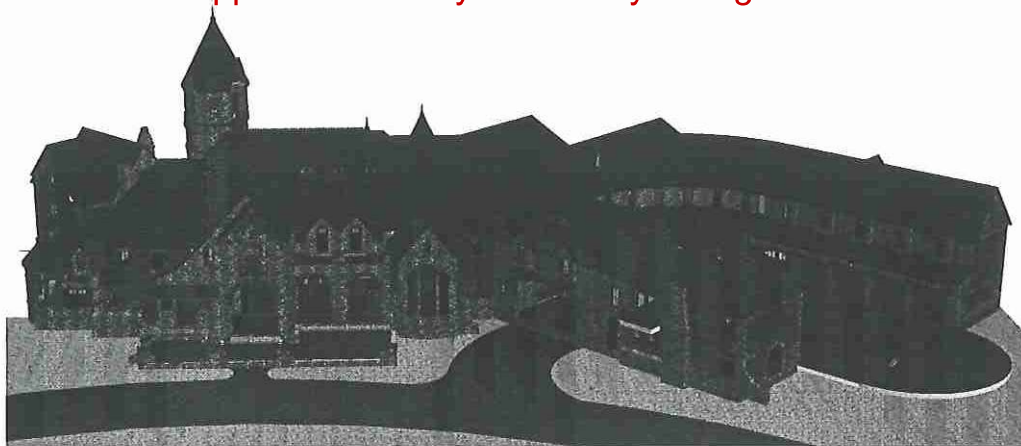

LEOPARD RIDGE DRAWING SCHEDULE

A-1 COVER PAGE
C-1 SITE GRADING PLAN
A-2 FOOTING PREP PLAN
A-3 SLAB AND HARDSCAPE ELEVATIONS
A-4 BASEMENT PLAN
A-5 MAIN FLOOR PLAN
A-6 SECOND FLOOR PLAN-THIRD FLOOR PLAN
A-7 BASEMENT CEILING PLAN
A-8 MAIN FLOOR CEILING PLAN
A-9 SECOND FLOOR CEILING PLAN
A-10 ROOF PLAN

A-11 TOWER PLANS AND ELEVATIONS
A-12 ELEVATIONS
A-13 ELEVATIONS
A-14 ELEVATIONS
A-15 ELEVATIONS
A-16 BUILDING SECTIONS
A-17 BUILDING SECTIONS
A-18 BUILDING SECTIONS
A-19 WALL SECTIONS
A-20 WALL SECTIONS
A-21 WALL SECTIONS

S-1 FOUNDATION PLAN
S-2 FOUNDATION WALL SECTIONS
S-3 FOUNDATION WALL SECTIONS
S-4 FOUNDATION WALL SECTIONS
S-5 BASEMENT STEEL FRAMING PLAN
S-6 MAIN, SECOND, TOWER STEEL FRAMING PLANS
S-7 TOWER FRAMING SECTION
S-8 TOWER FRAMING DETAIL
S-9 TOWER STRUCTURE OVERVIEW

E-1 BASEMENT LIGHTING PLAN
E-2 MAIN FLOOR LIGHTING PLAN
E-3 SECOND FLOOR LIGHTING PLAN
E-4 THIRD FLOOR LIGHTING PLAN
E-5 BASEMENT POWER PLAN
E-6 MAIN FLOOR POWER PLAN
E-7 SECOND FLOOR POWER PLAN
E-8 THIRD FLOOR POWER PLAN
E-9 PANEL SCHEDULES

SUPPLEMENTAL SHEETS
* GUEST HOUSE / OUTDOOR LIVING / HOT TUB
* BASEMENT
* MAIN FLOOR
* SECOND FLOOR
* EXTERIOR DETAIL COMPONENTS
* SCHEDULES

SQAURE FOOTAGE STATISTICS

HOUSE FOOTPRINT	16604	SGFT	
HOUSE PERIMETER	1155.25	LNFT	
OBSERVATION	+ 154	SGFT	TOTALS
TOWER LANDING TWO	+ 154	SGFT	154
THIRD			
+ TOWER LANDING ONE	154		
+ BEDROOM LOFTS	292		
+ LIVING AREA	+ 446	SGFT	446
SECOND FLOOR			
+ RECREATION / BAND ROOM	1514		
+ LEARNING CENTER	1454		
+ CARRIAGE HOUSE	1145		
+ GUEST HOUSE LOFT	403		
STORAGE / MECHANICAL	681		
+ LOFT AREA / LAUNDRY / L.G. BATH	2053		
DECKS AND BALCONIES	425		
+ BEDROOMS	2657		
+ LIVING AREA	+ 4226	SGFT	10832
MAIN FLOOR			
+ MASTER SUITE	3173		
MASTER DECK	352		
MAIN GARAGE	1664		
STORAGE	200		
CARRIAGE GARAGE	1145		
PORTE-COCHERE	704		
GARAGE VERANDA	558		
MOTORCOURT	5687		
+ MAIN AREA	6576		
FRONT VERANDA	426		
OUTDOOR DECK	1399		
GUEST SCREENED PORCH	105		
OUTDOOR LIVING	813		
+ GUEST HOUSE MAIN	912		
FRONT COURTYARD	1287		
FORMAL GARDEN	1560		
+ LIVING AREA	+ 10661	SGFT	26361
BASEMENT			
+ ENTERTAINMENT	4941		
+ EXERCISE - LOCKER	2620		
STORM SHELTER	461		
STORAGE / MECAHNICAL	1405		
CORRIDORS	1815		
PATIOS	1410		
DECKS AND BALCONIES	113		
POOL	2163		
POOL TERRACE	4000		
+ POOL BATHS	284		
SIDEWALKS	1200		
+ LIVING AREA	+ 7845	SGFT	20412
TOTAL LIVING AREA	28486	SGFT	58359

Lifestyle
HOMES



Security Design Group
417.838.6443 • jj@hetheringtondesign.com

LEOPARD RIDGE
A PRIVATE RESIDENCE

HETHERINGTON
DESIGN & CONSULTING
417.838.6443 • jj@hetheringtondesign.com



DATE
5/24/2012

SCALE
PER DRAWING

PHASE DESCRIPTION
COVER

SHEET

A-1


Lifestyle
HOMES
Builder / Contractor



Security Design Group



P.O. BOX 3392
SPRINGFIELD, MISSOURI 65806

417.869.7100
417.889.0555
securitydesign@sdgmo.com

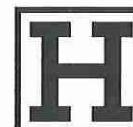

HETHERINGTON
DESIGN & CONSULTING
417.838.6443 • jj@hetheringtondesign.com

All numbers are approximate. Buyer and buyer agent to do own due diligence.

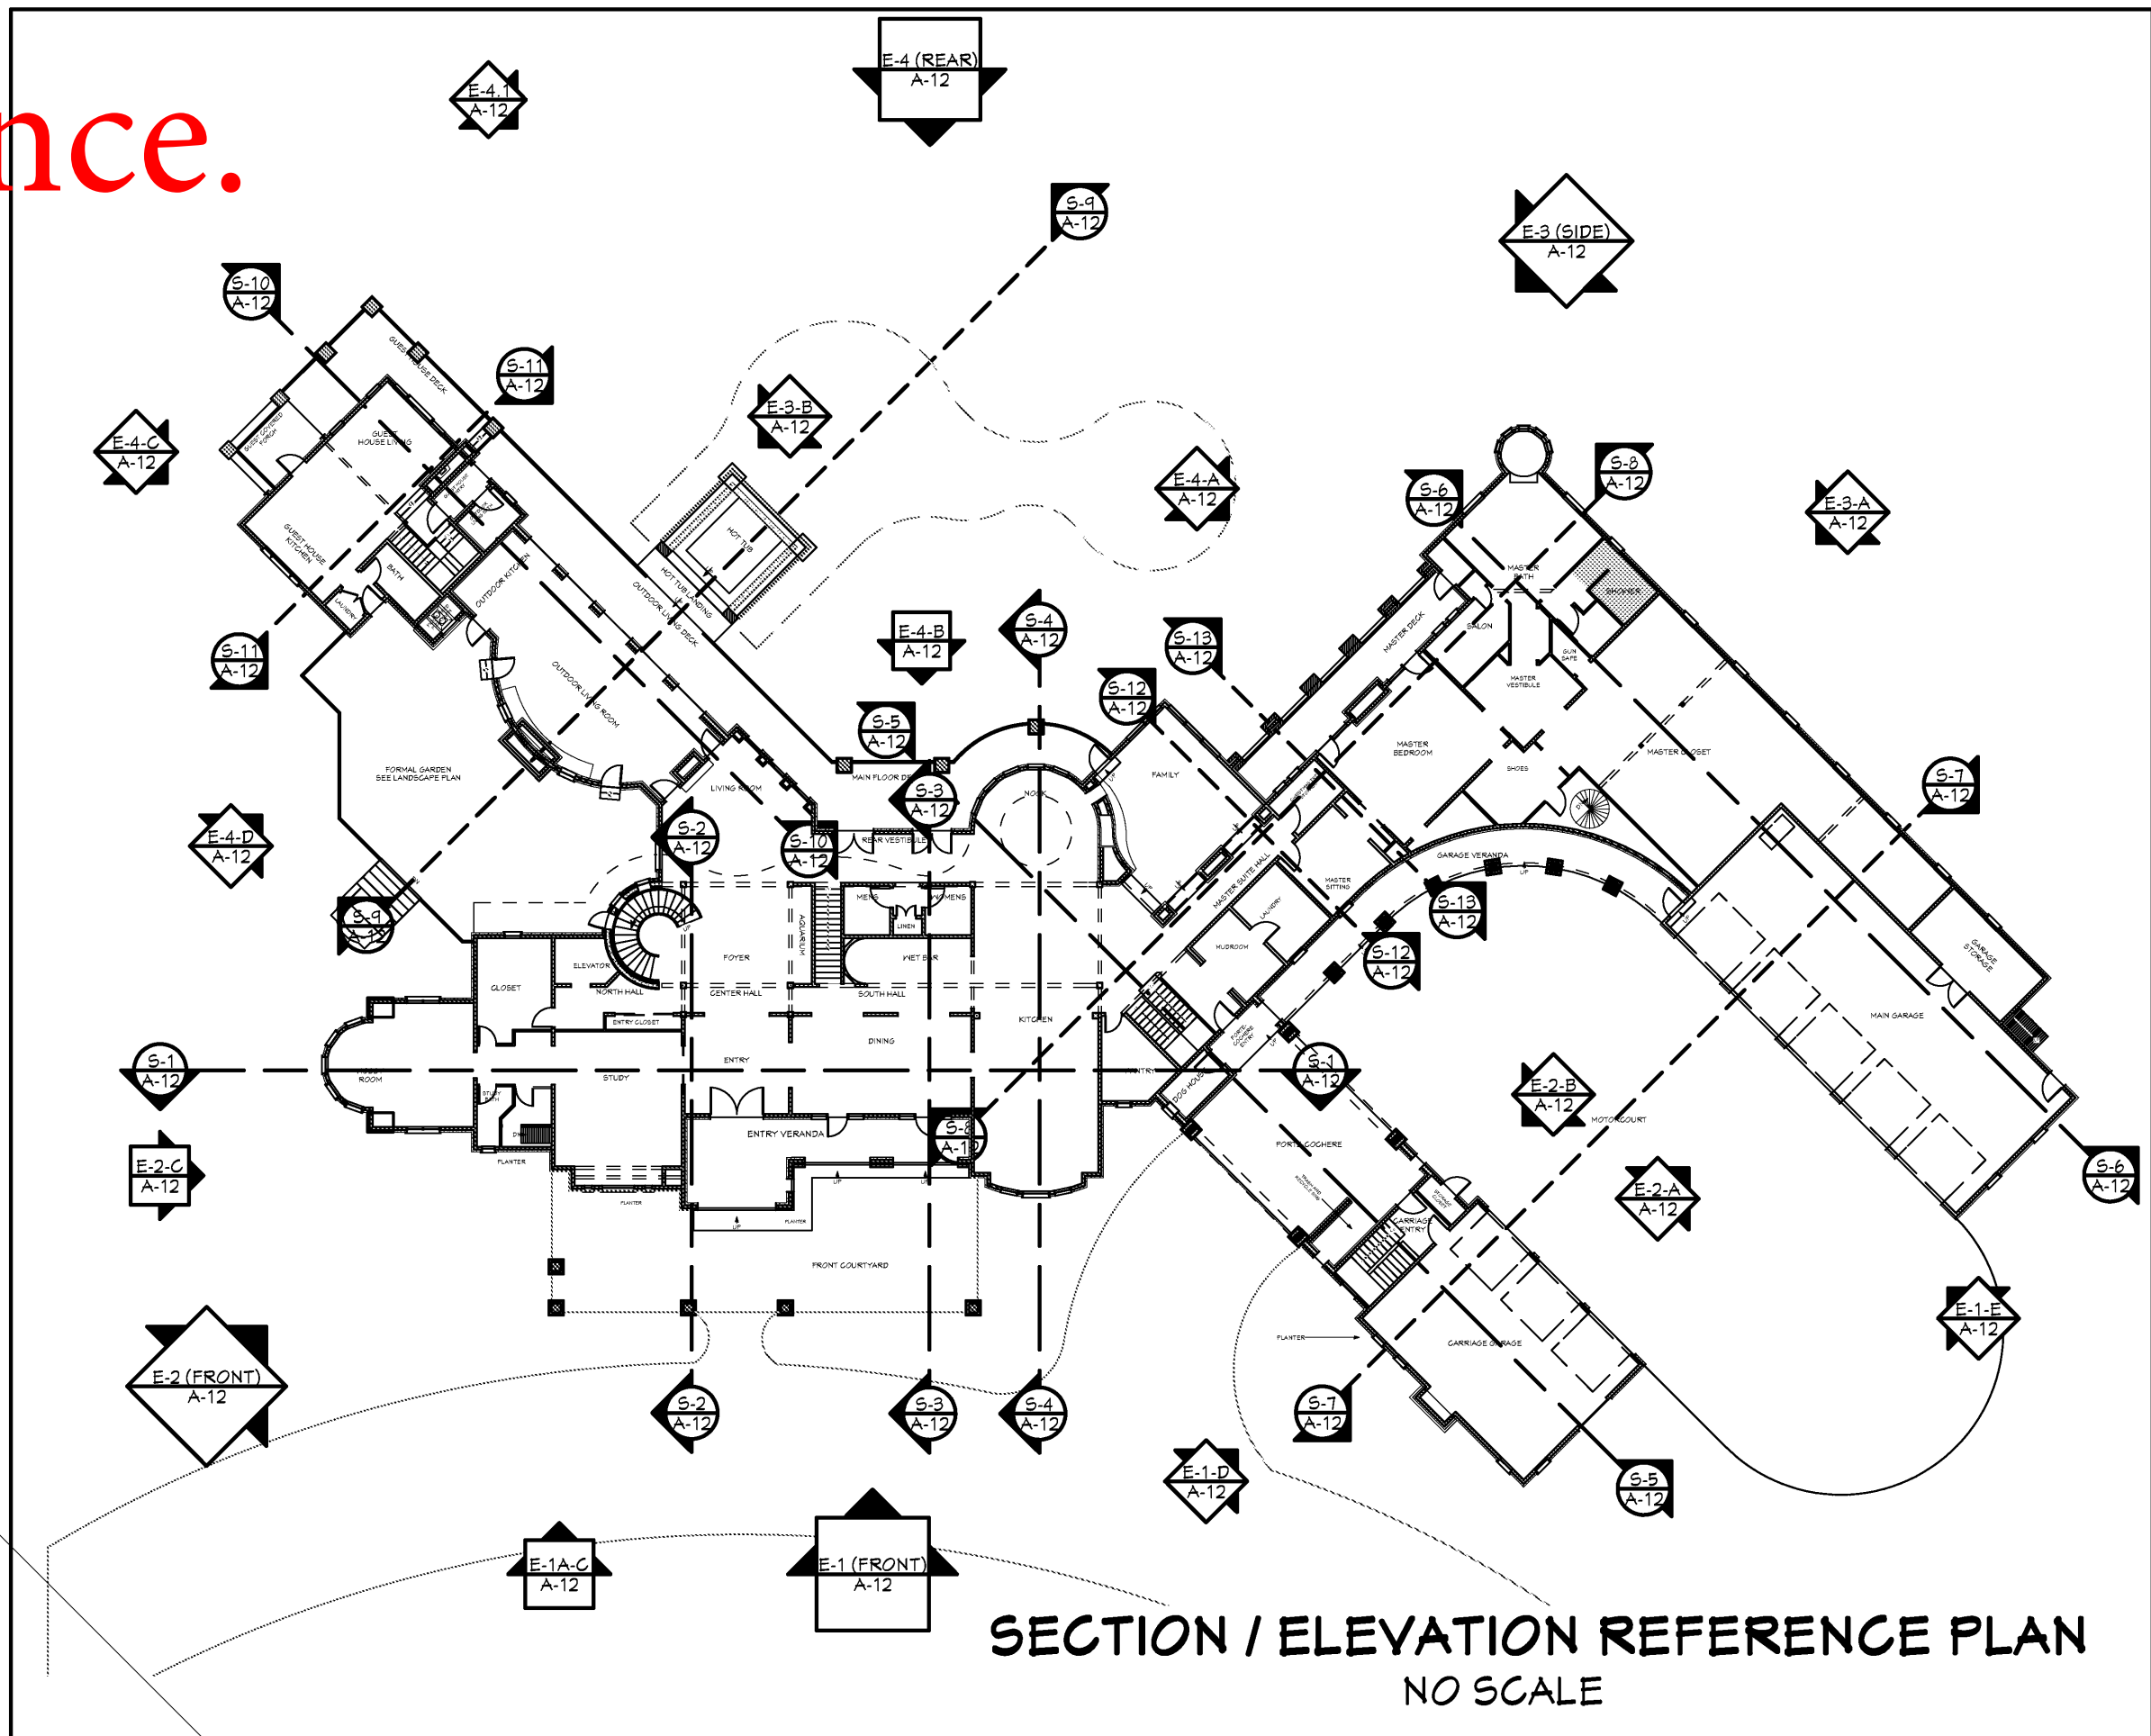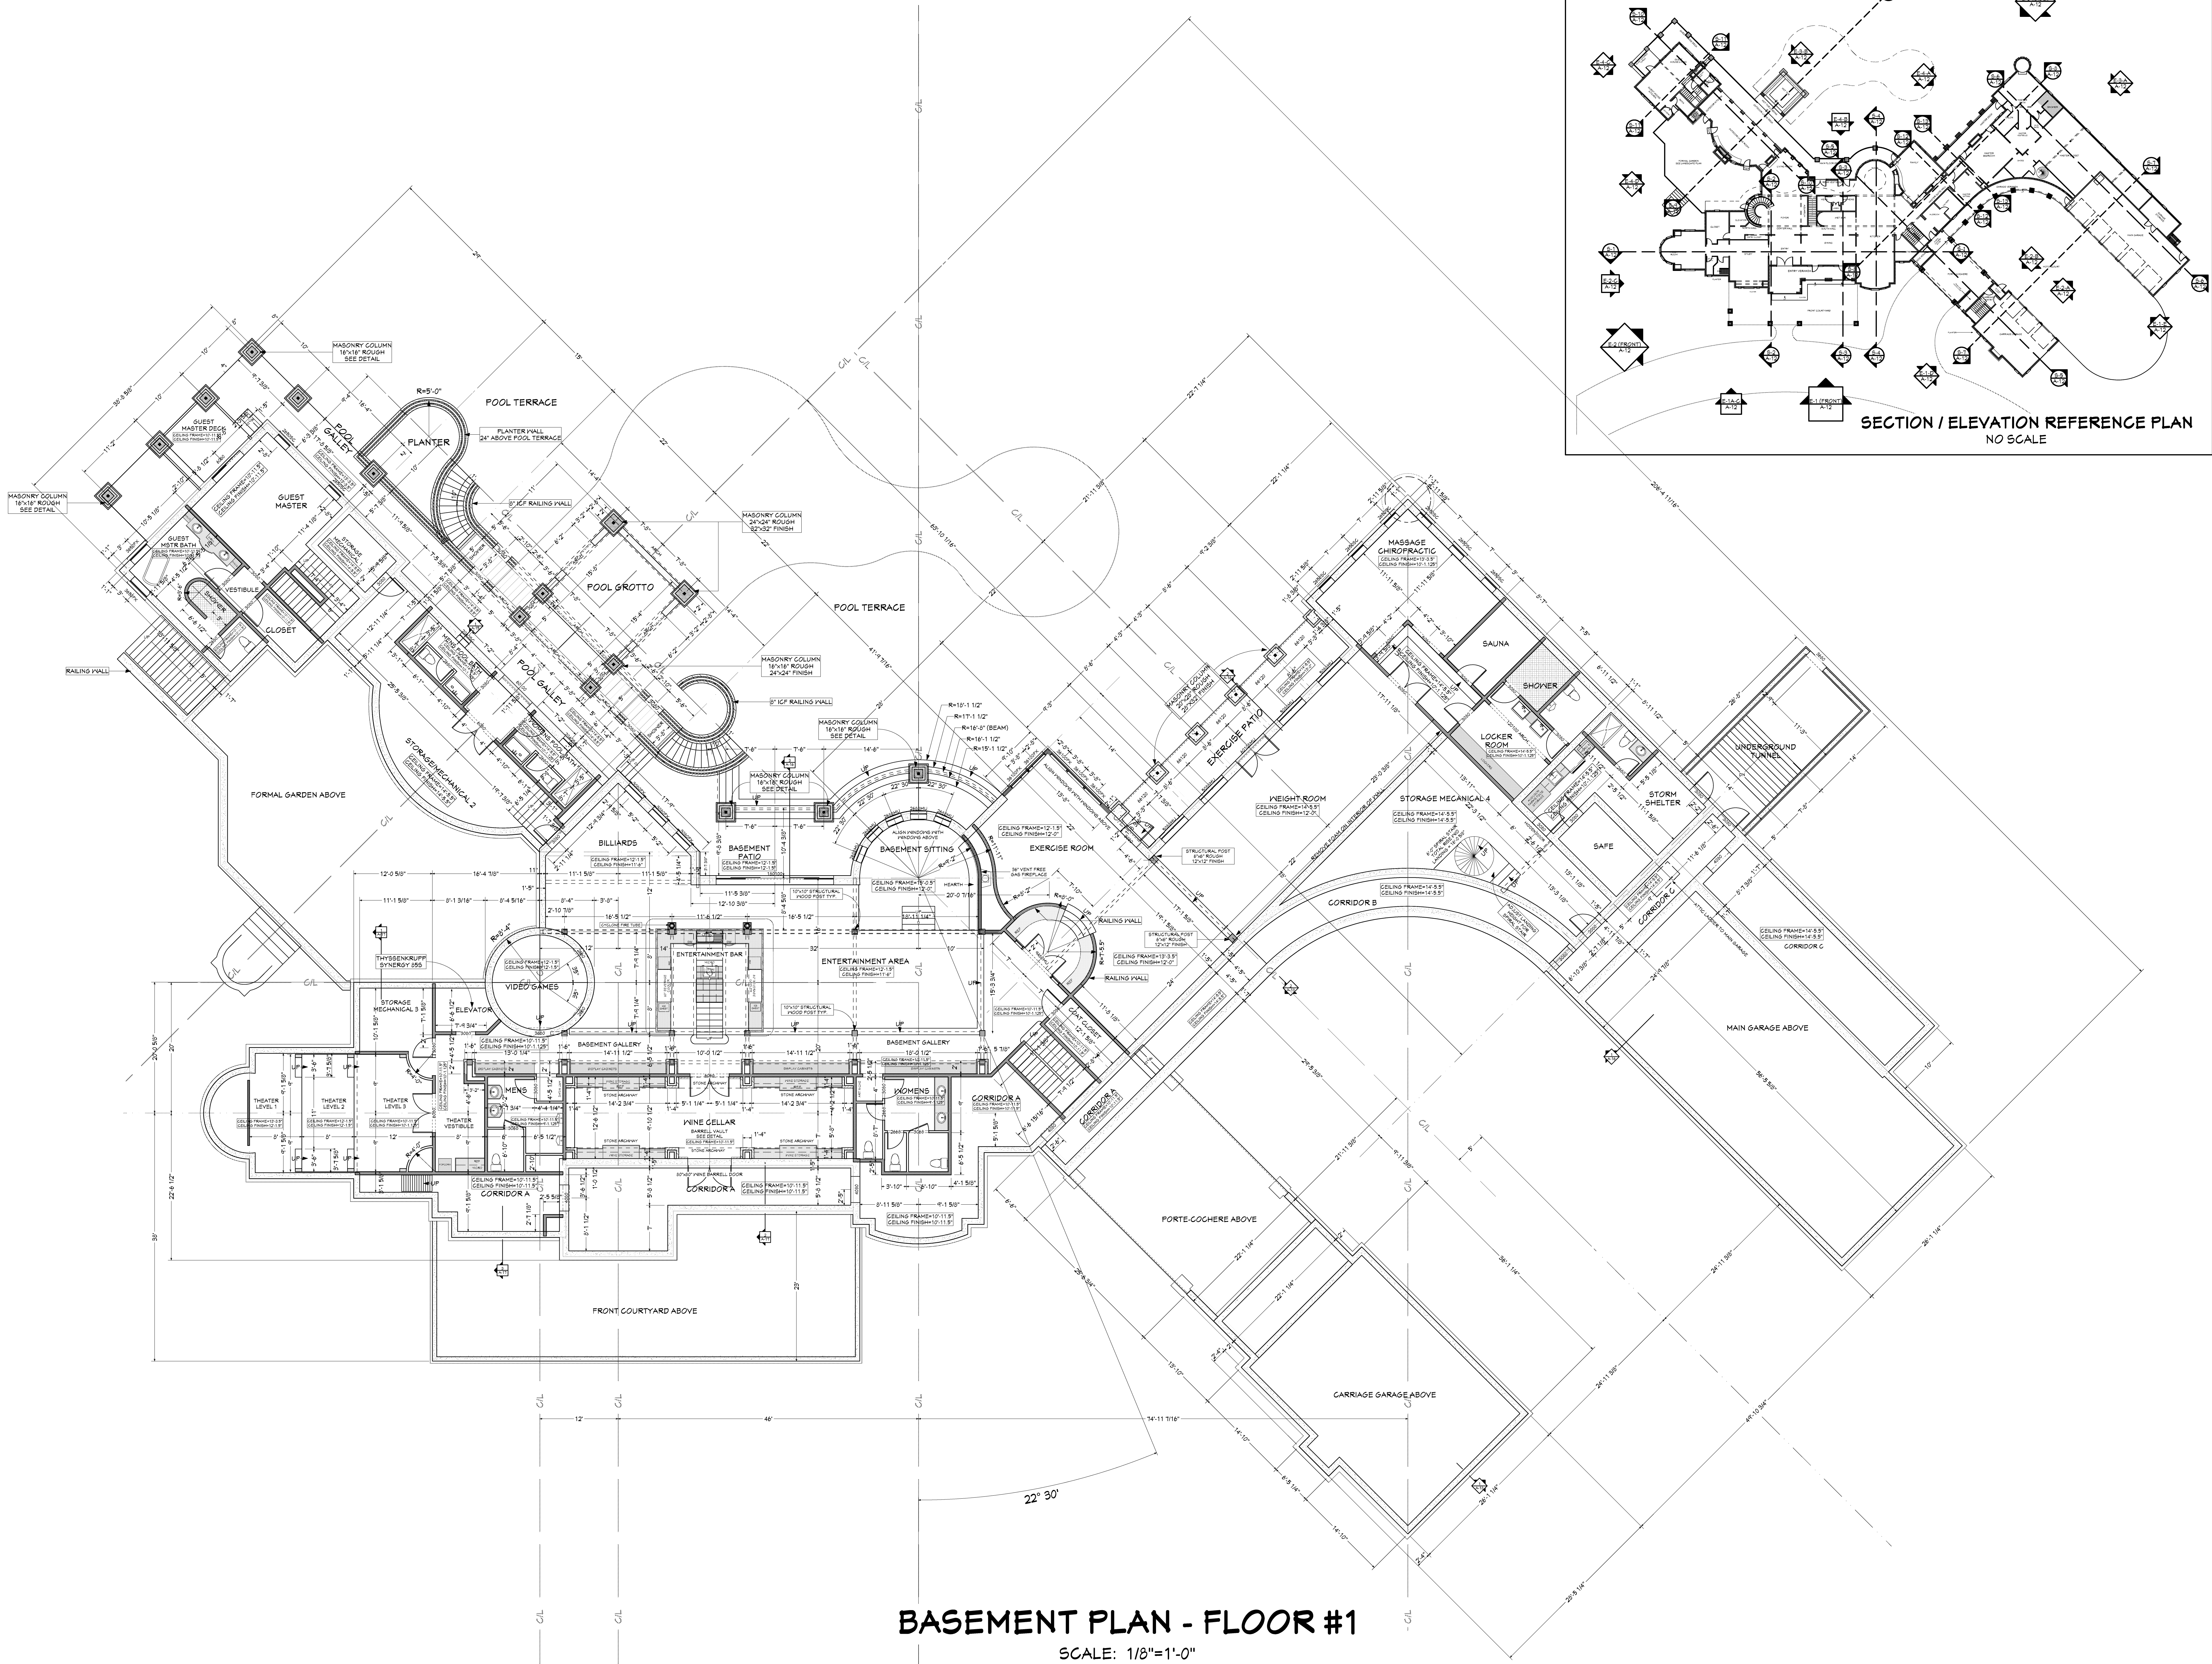

Lifestyle
HOMES
Builder's Choice

STICKS
STONES

Security Design Group
417.888.6443
www.securitydesigngroup.com


LEOPARD RIDGE
A PRIVATE RESIDENCE

HETHERINGTON
DESIGN & CONSULTING
417.888.6443 • @hetheringtondesign


H

DATE
5/29/2012
SCALE
PER DRAWING
PAGE DESCRIPTION
BASEMENT
PLAN
SHEET
A-4

All numbers are approximate. Buyer and buyer agent to do own due diligence.

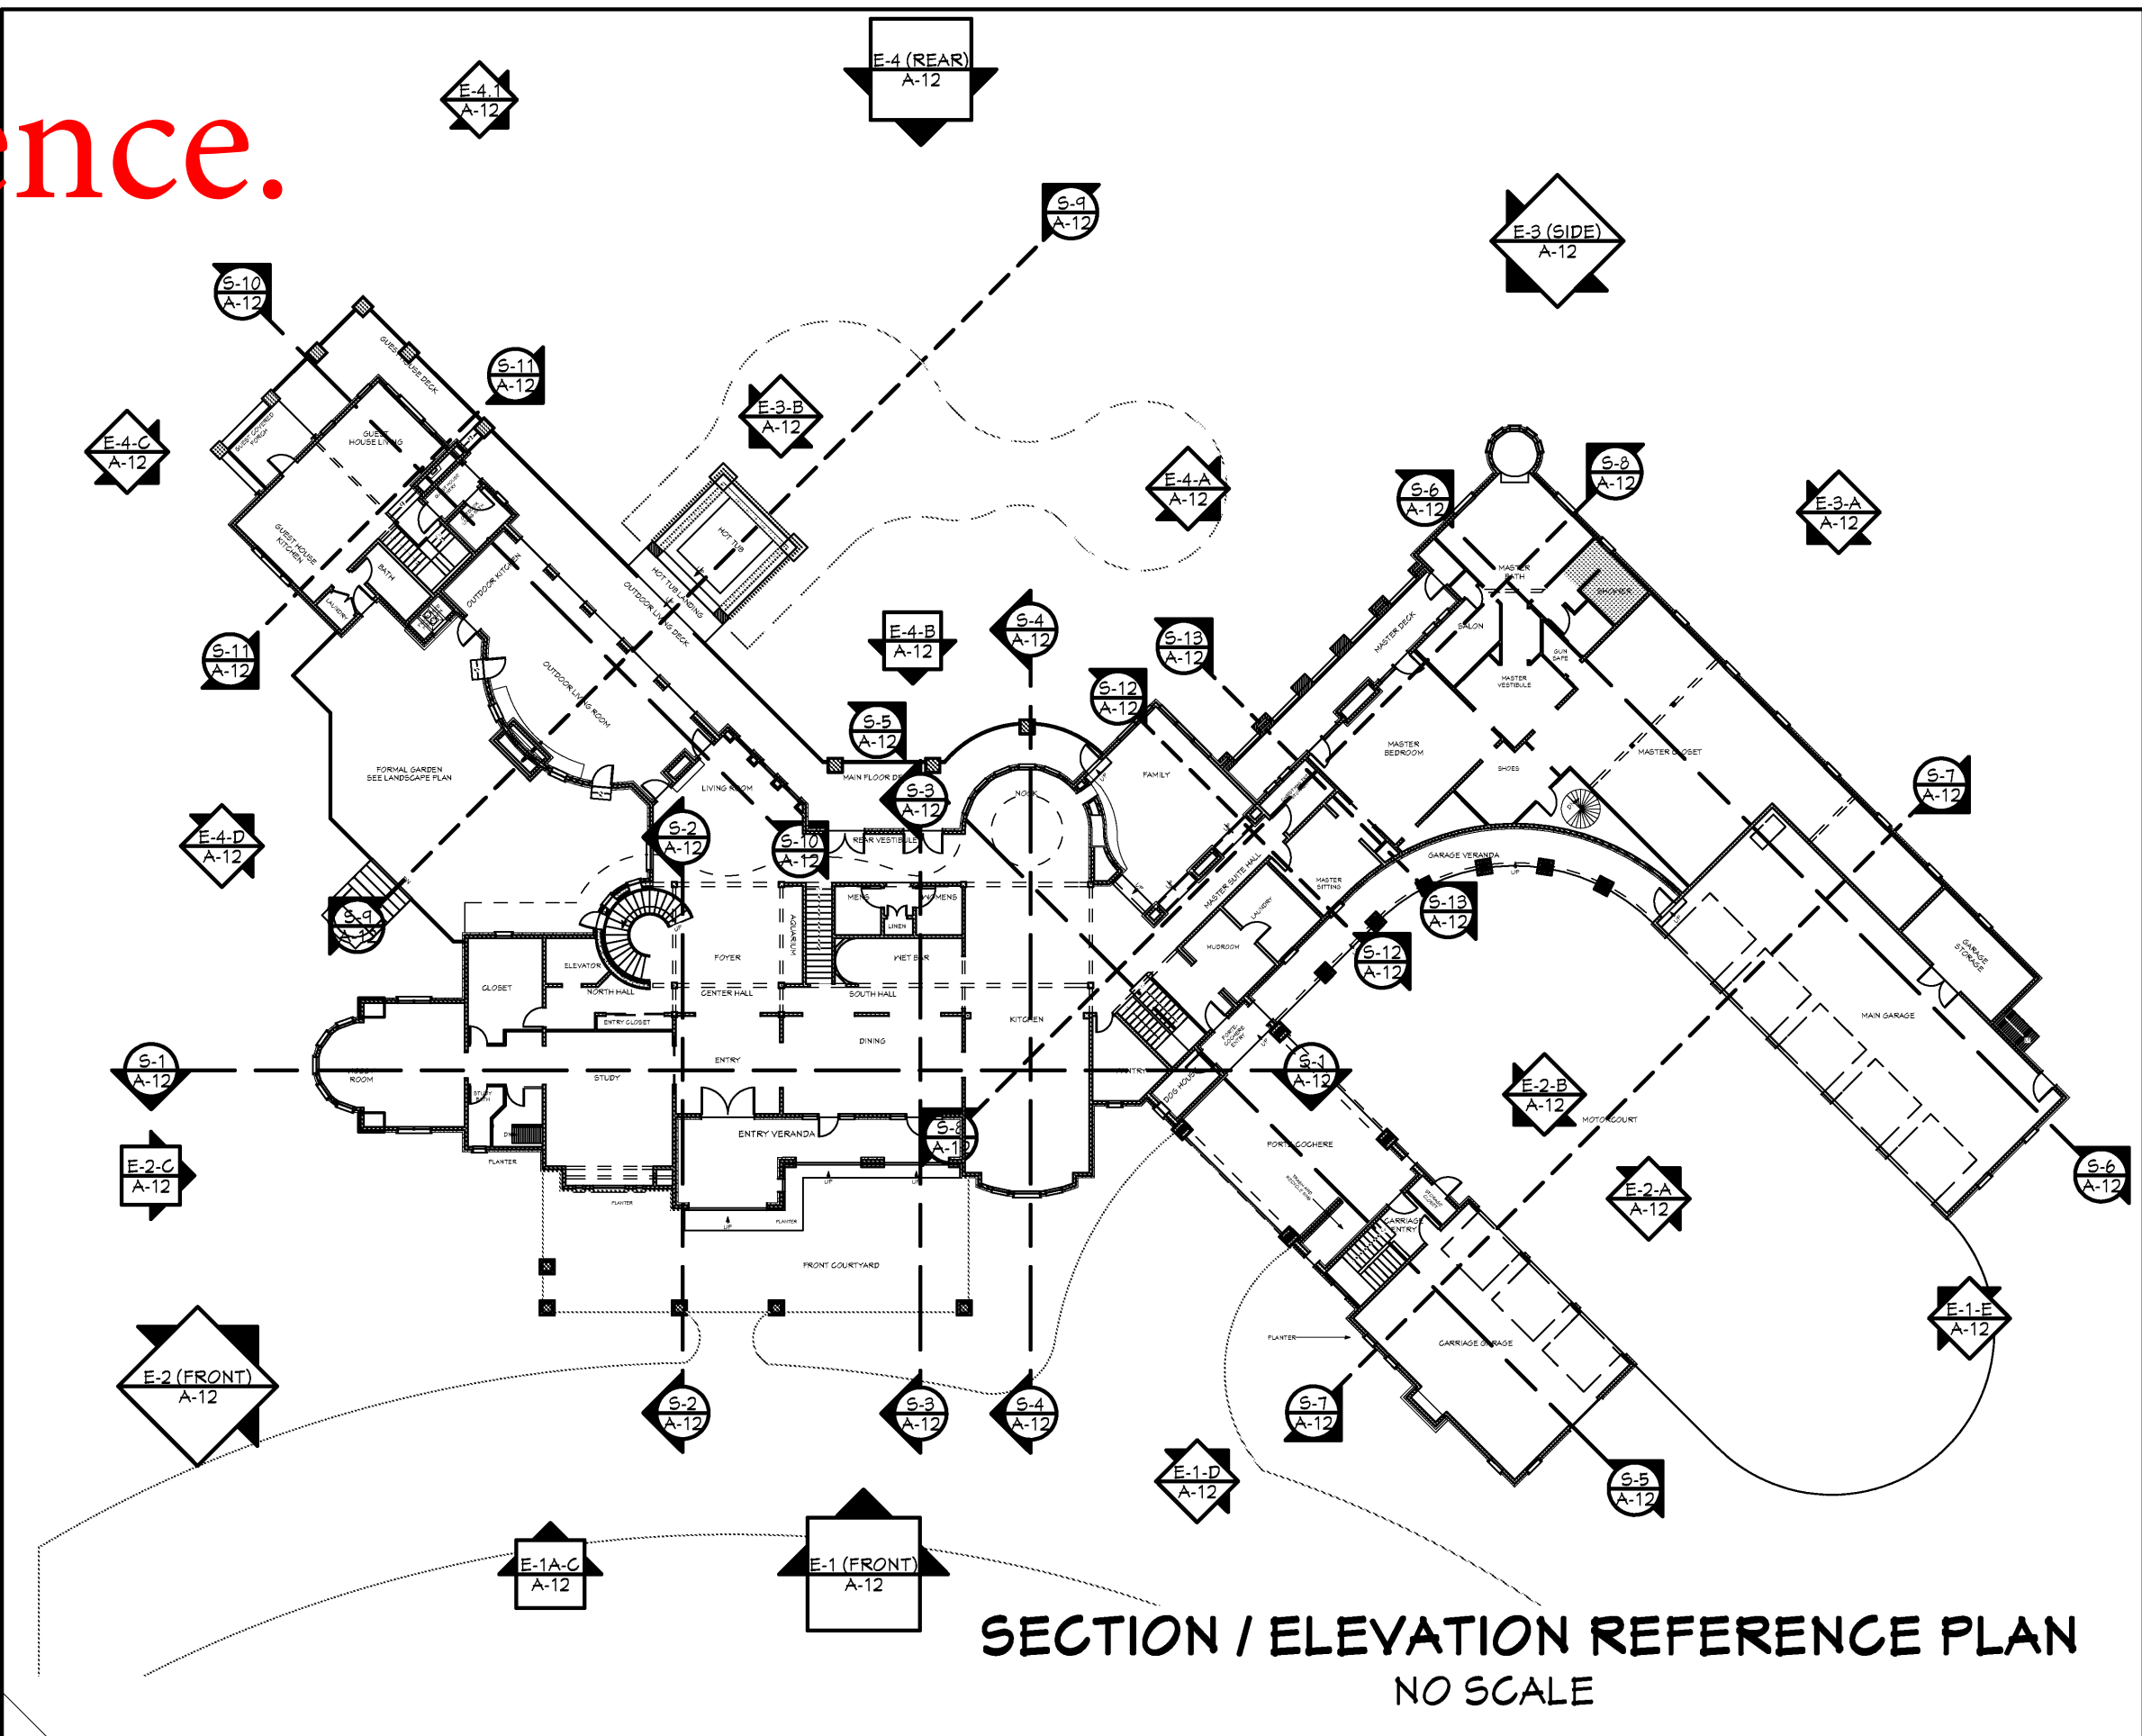

SECTION / ELEVATION REFERENCE PLAN
NO SCALE

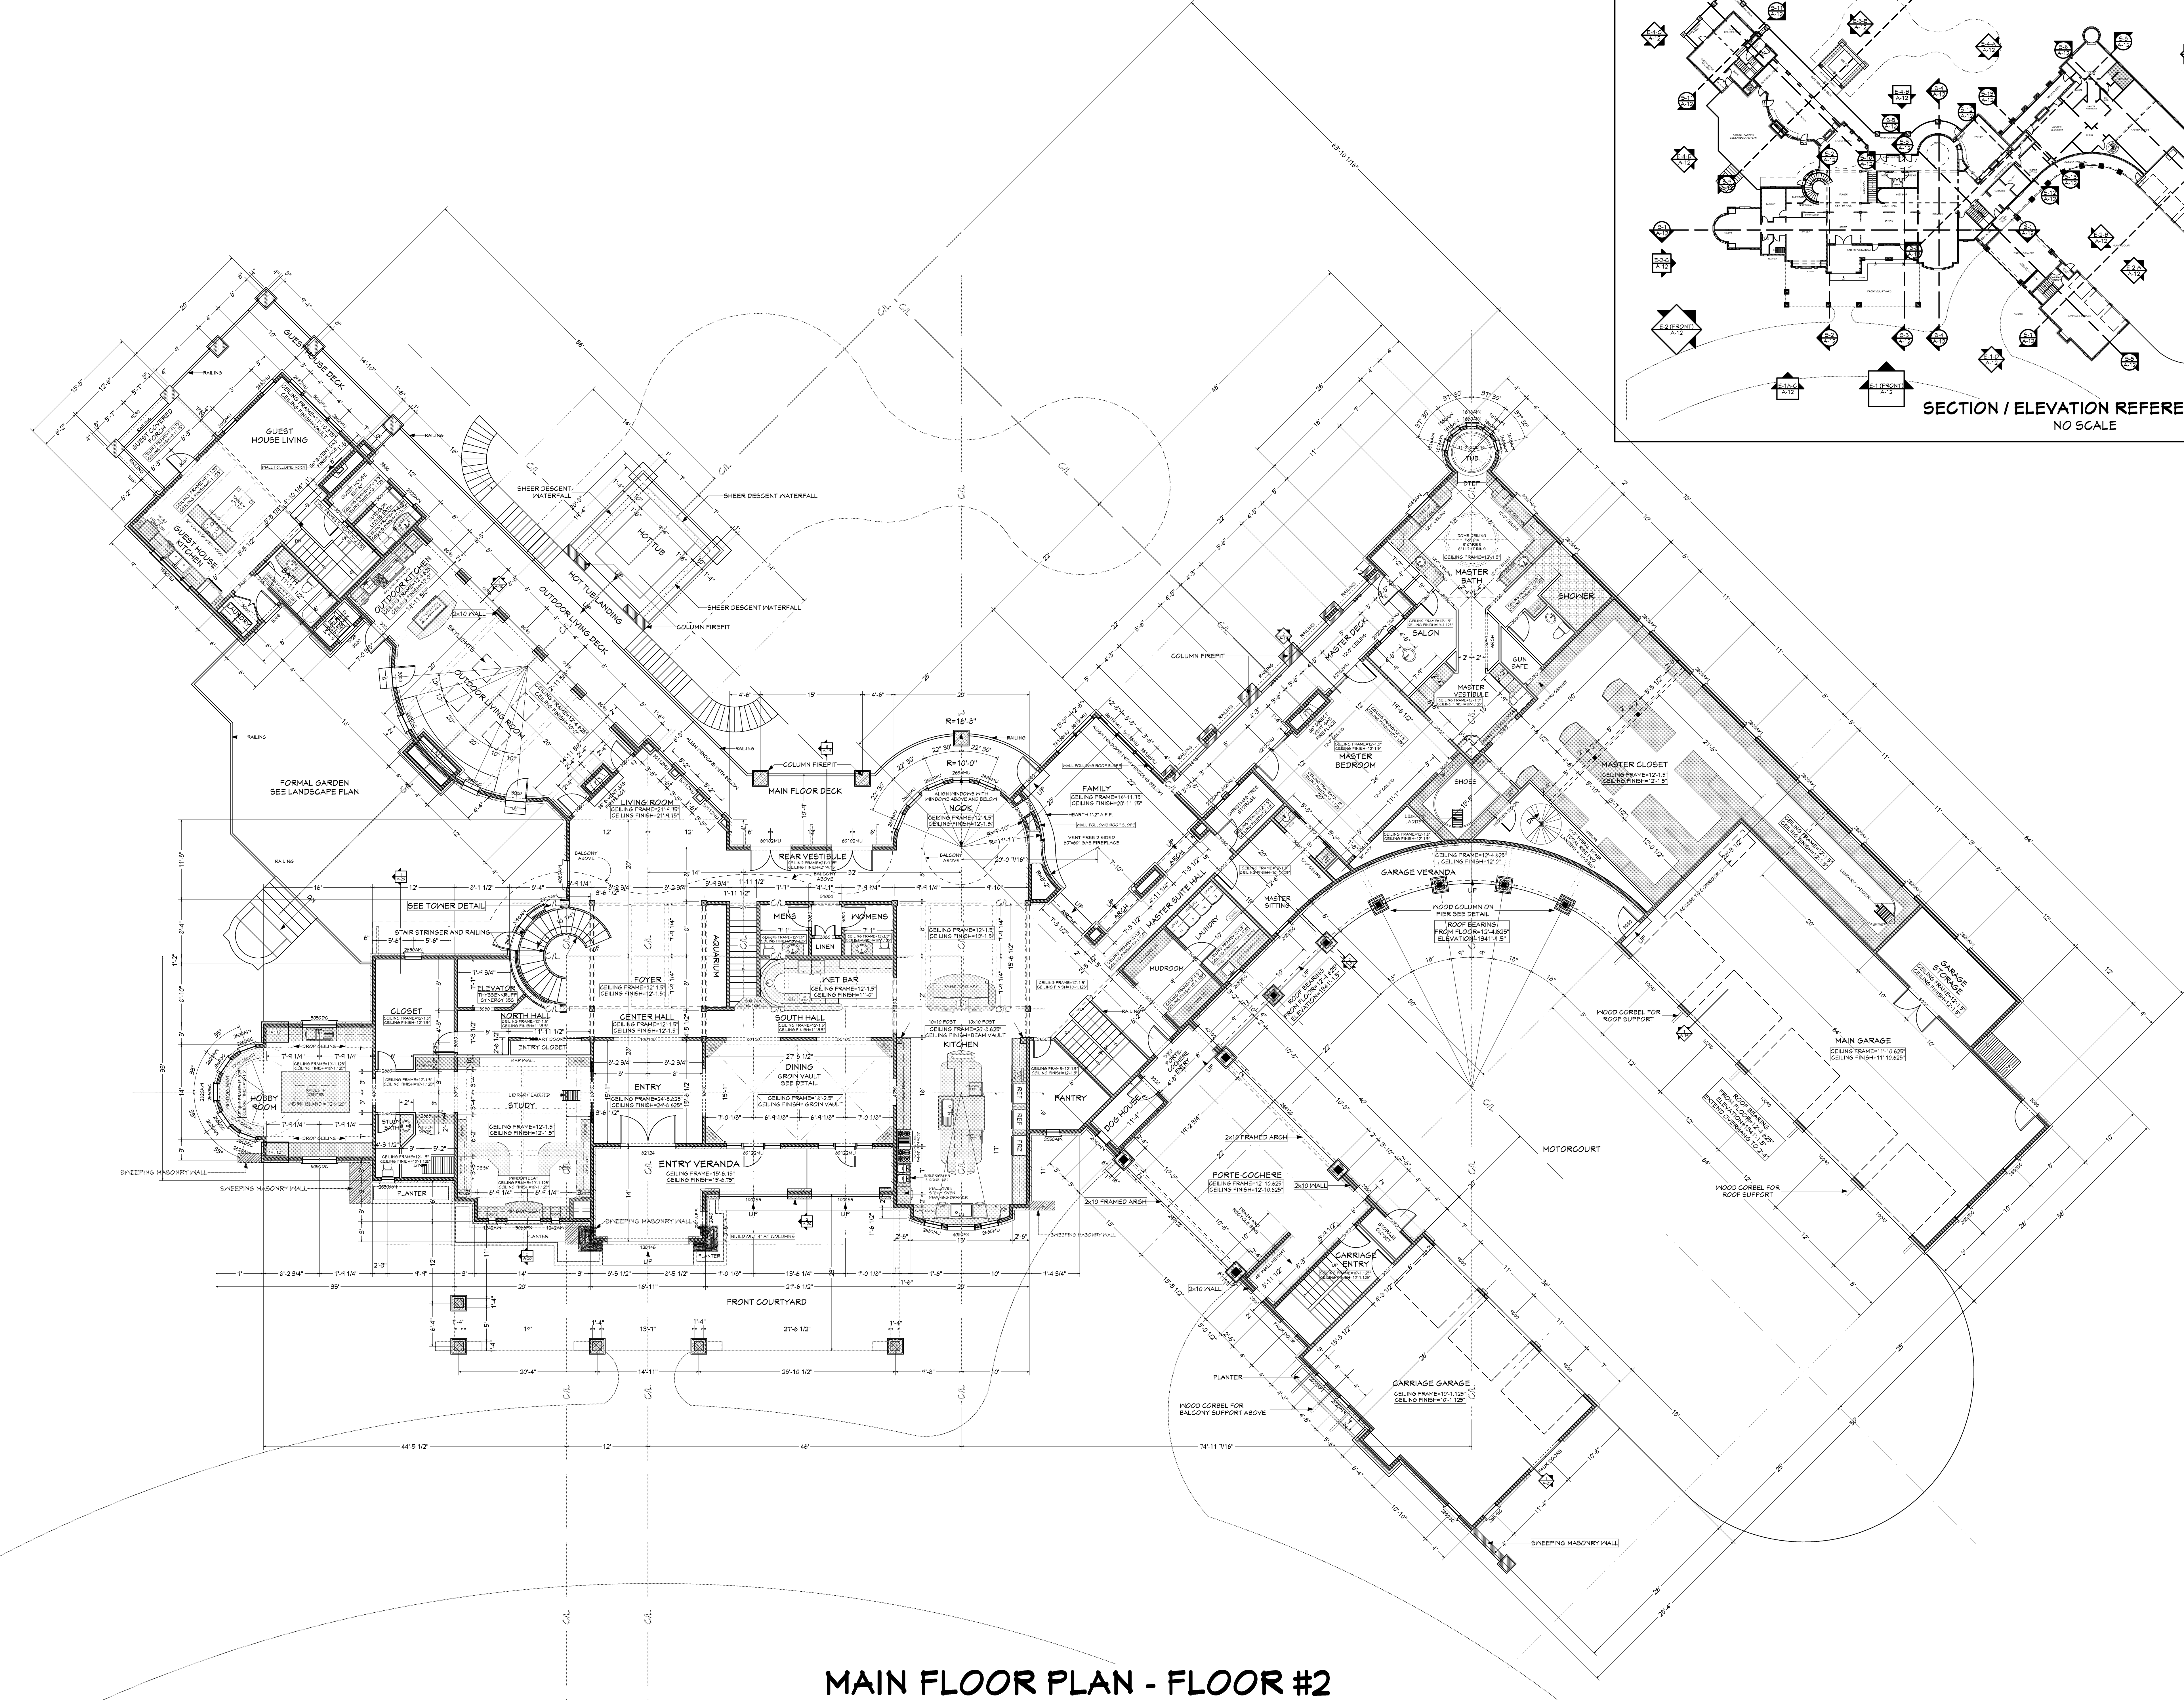

MAIN FLOOR PLAN - FLOOR #2
SCALE: 1/8"=1'-0"


Lifestyle
HOMES
Builder's Choice

STICKS
STONES

Security Design Group
417.888.6443
www.securitydesigngroup.com

LEOPARD RIDGE
A PRIVATE RESIDENCE







HETHERINGTON
DESIGN & CONSULTING
417.888.6443 • @hetheringondesign.com

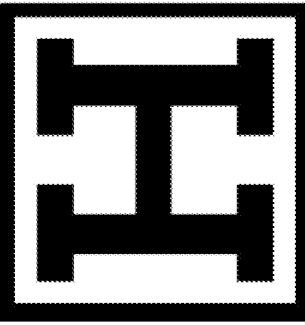

DATE
5/29/2012
SCALE
PER DRAWING
PAGE DESCRIPTION
MAIN FLOOR PLAN
SHEET
A-5

Copyright © 2011: This document is for the exclusive use of Hetherington Design and Consulting (HDC). All rights reserved by HDC. Do not reproduce, alter, or display without the written consent and/or release of HDC.

All numbers are approximate. Buyer and buyer agent to do own due diligence.

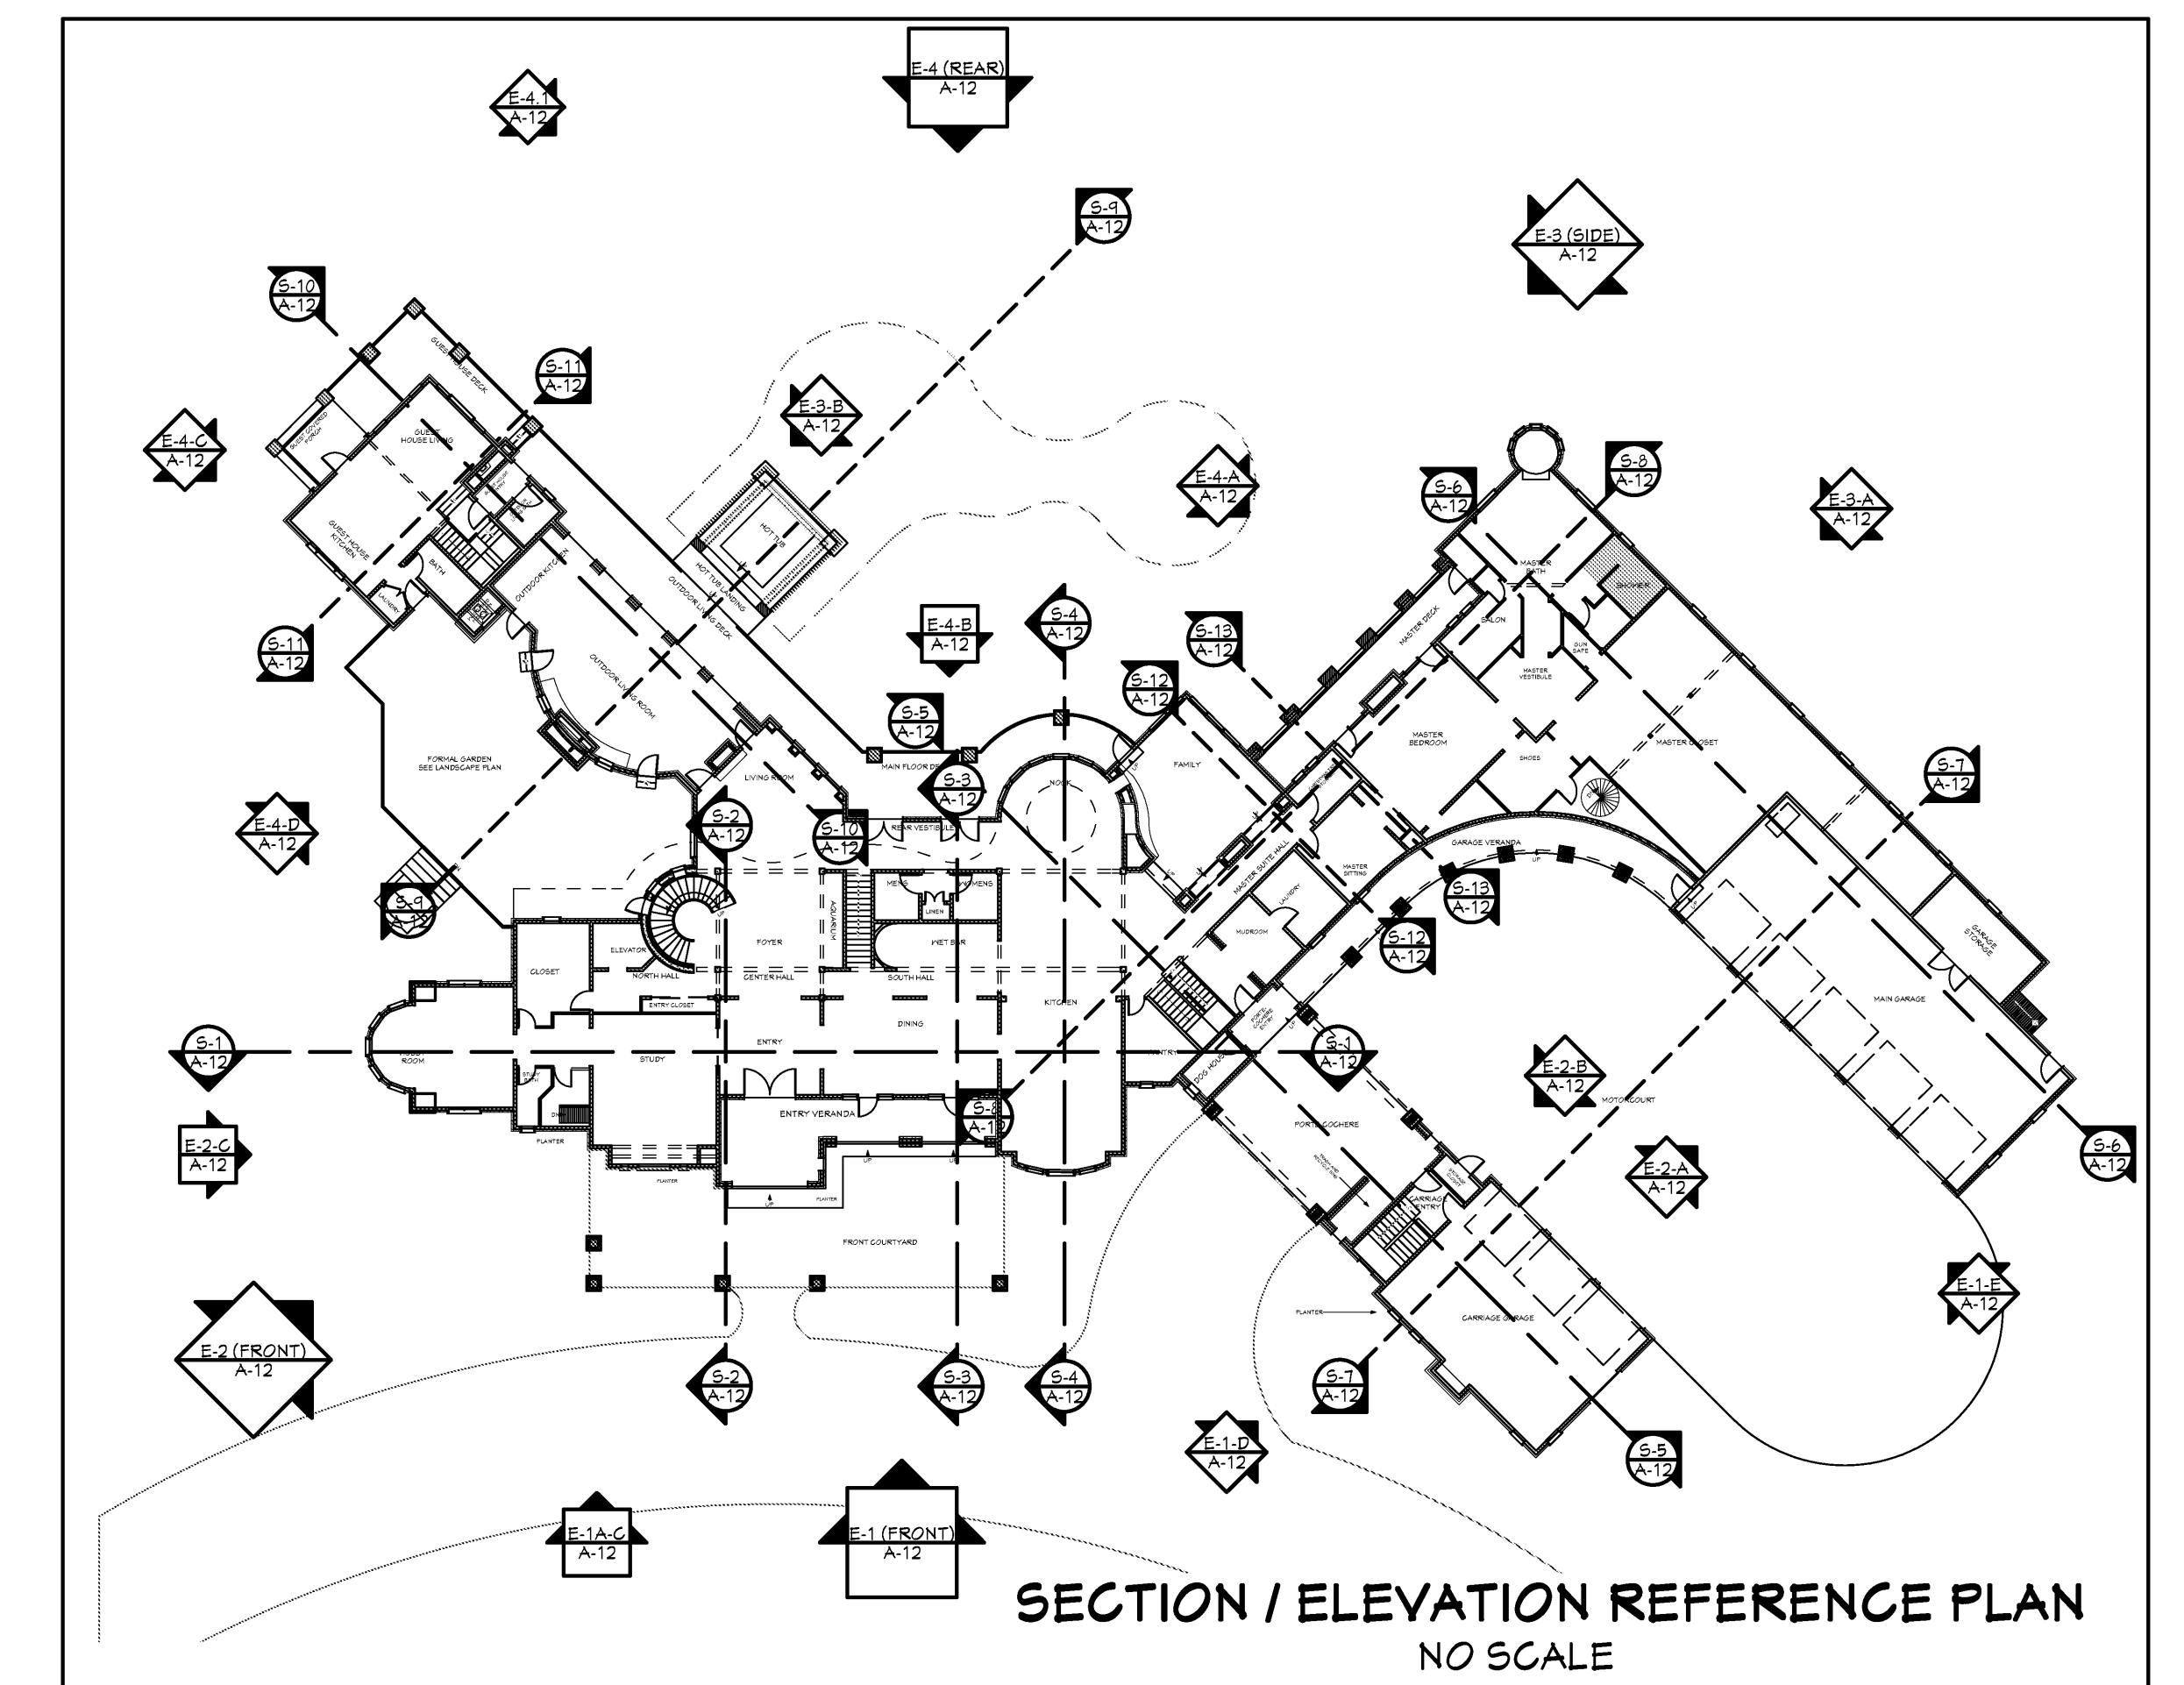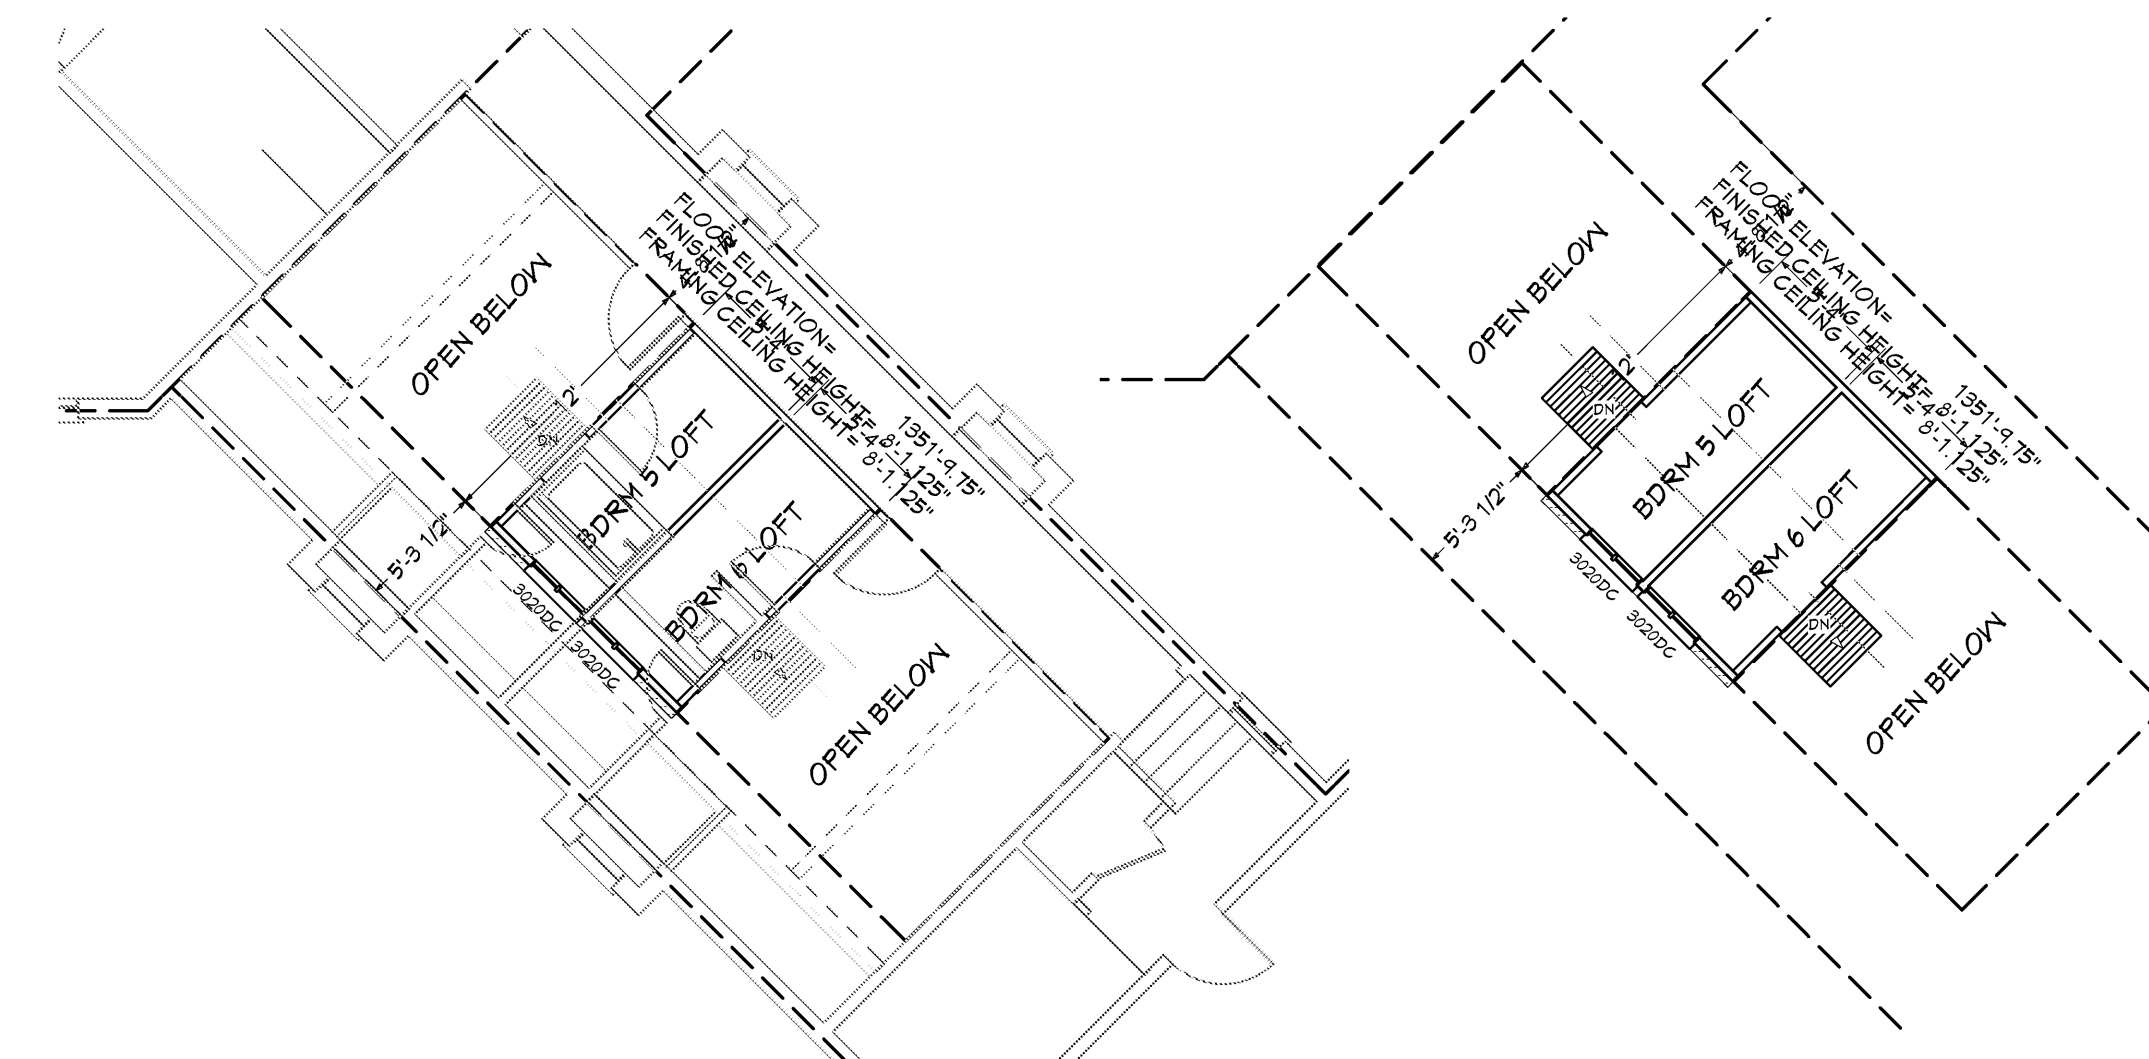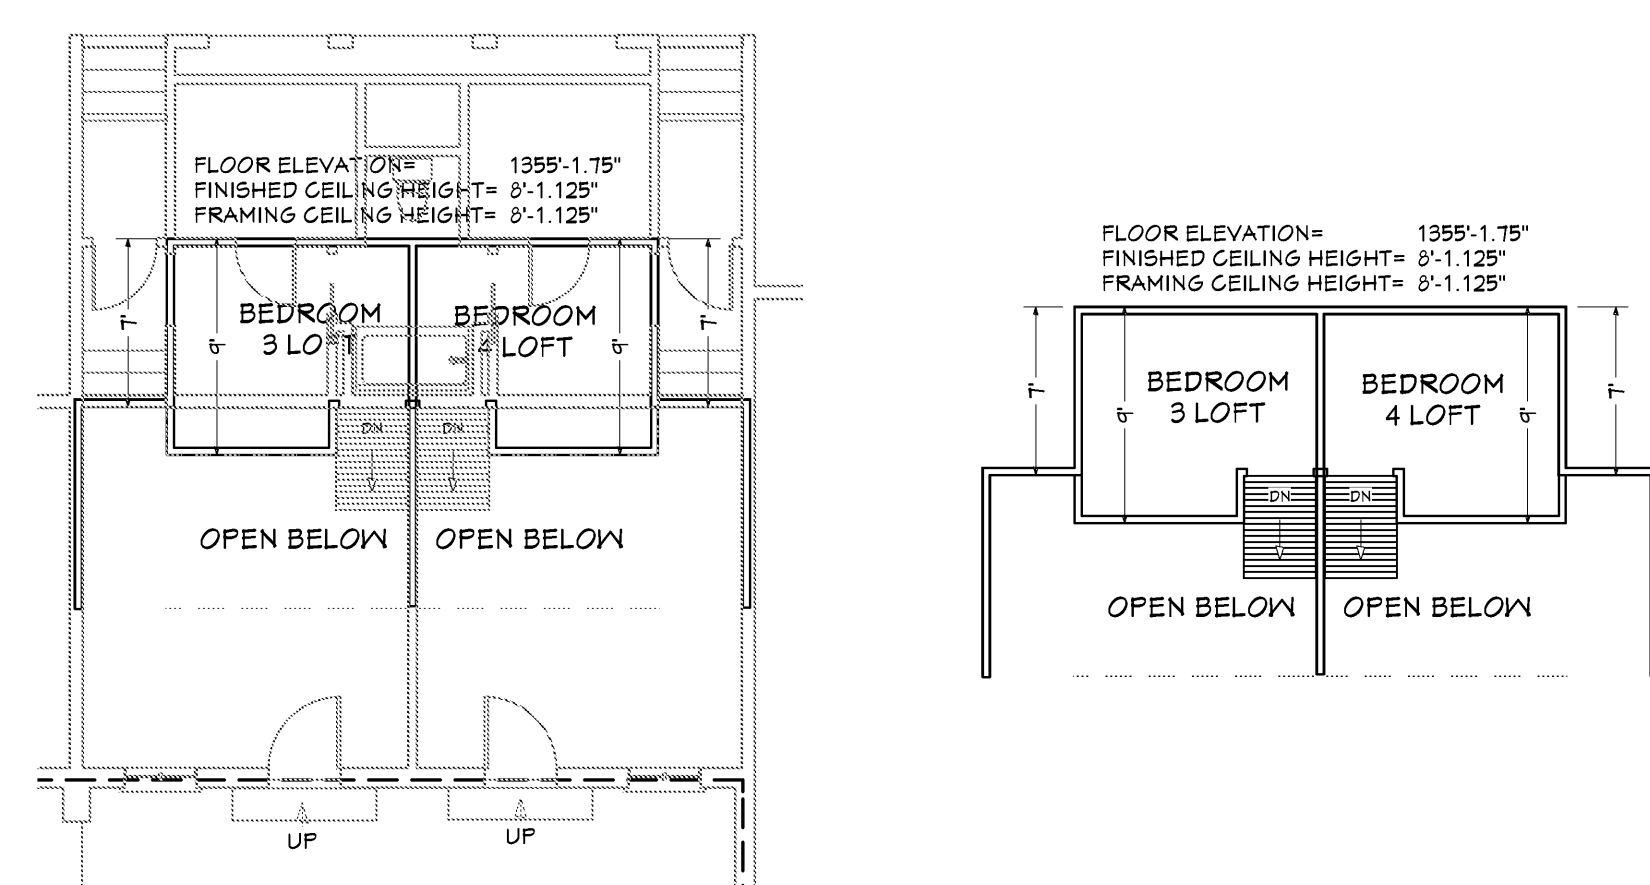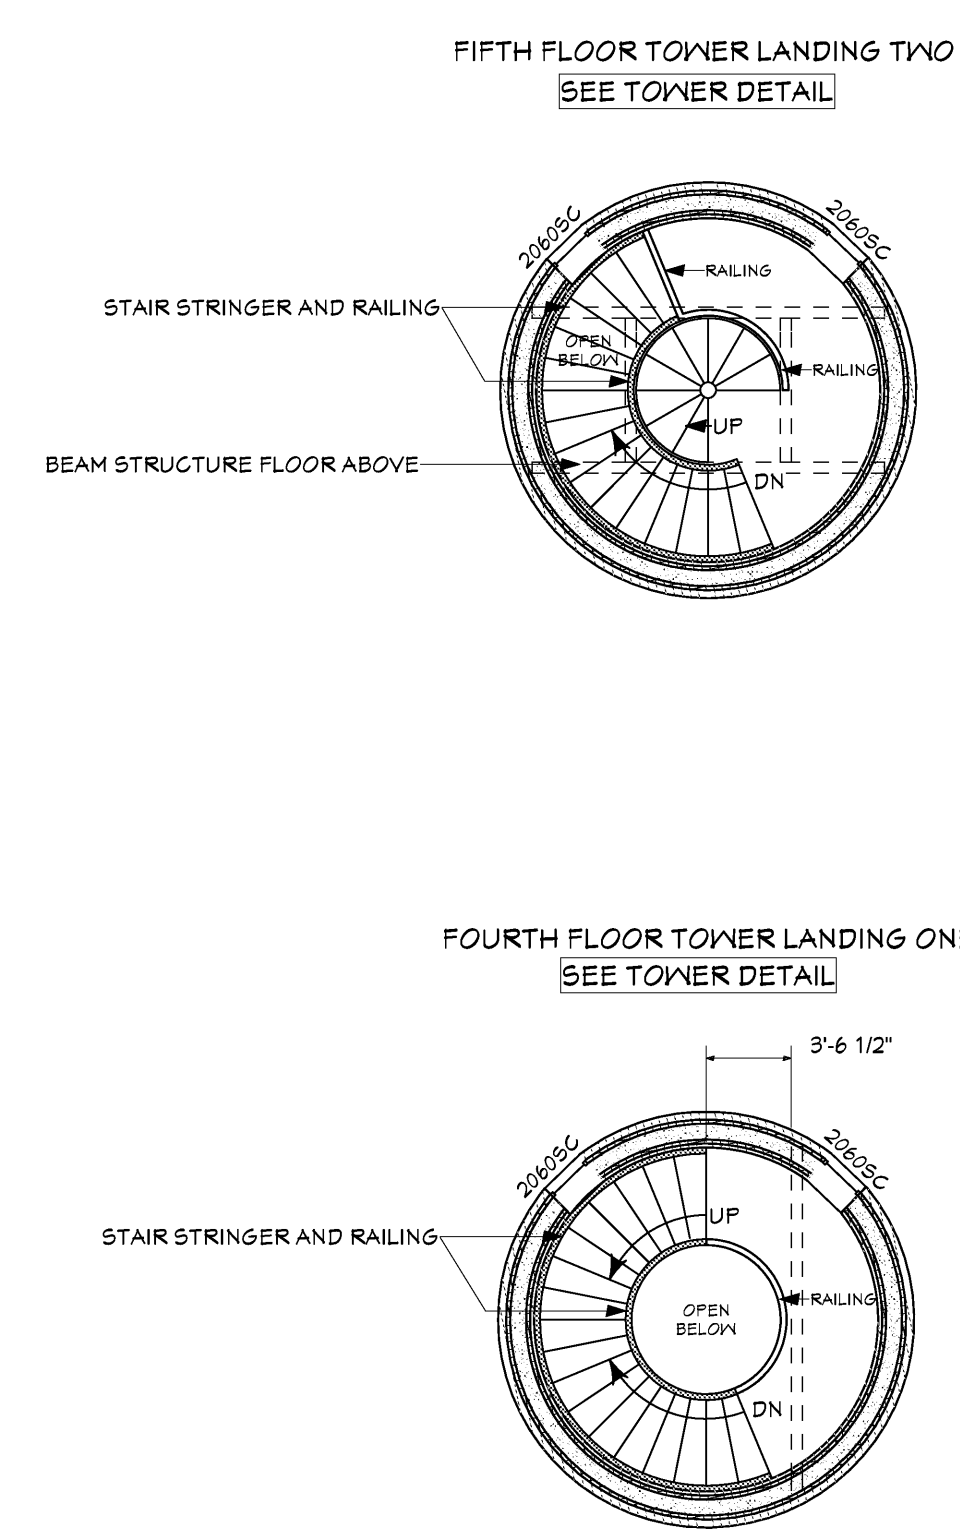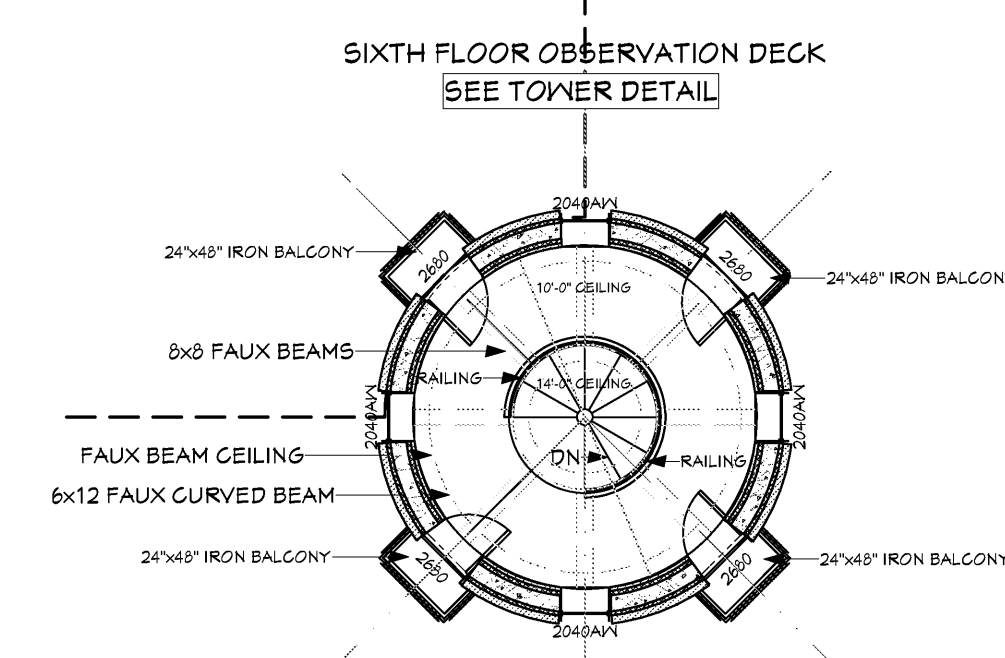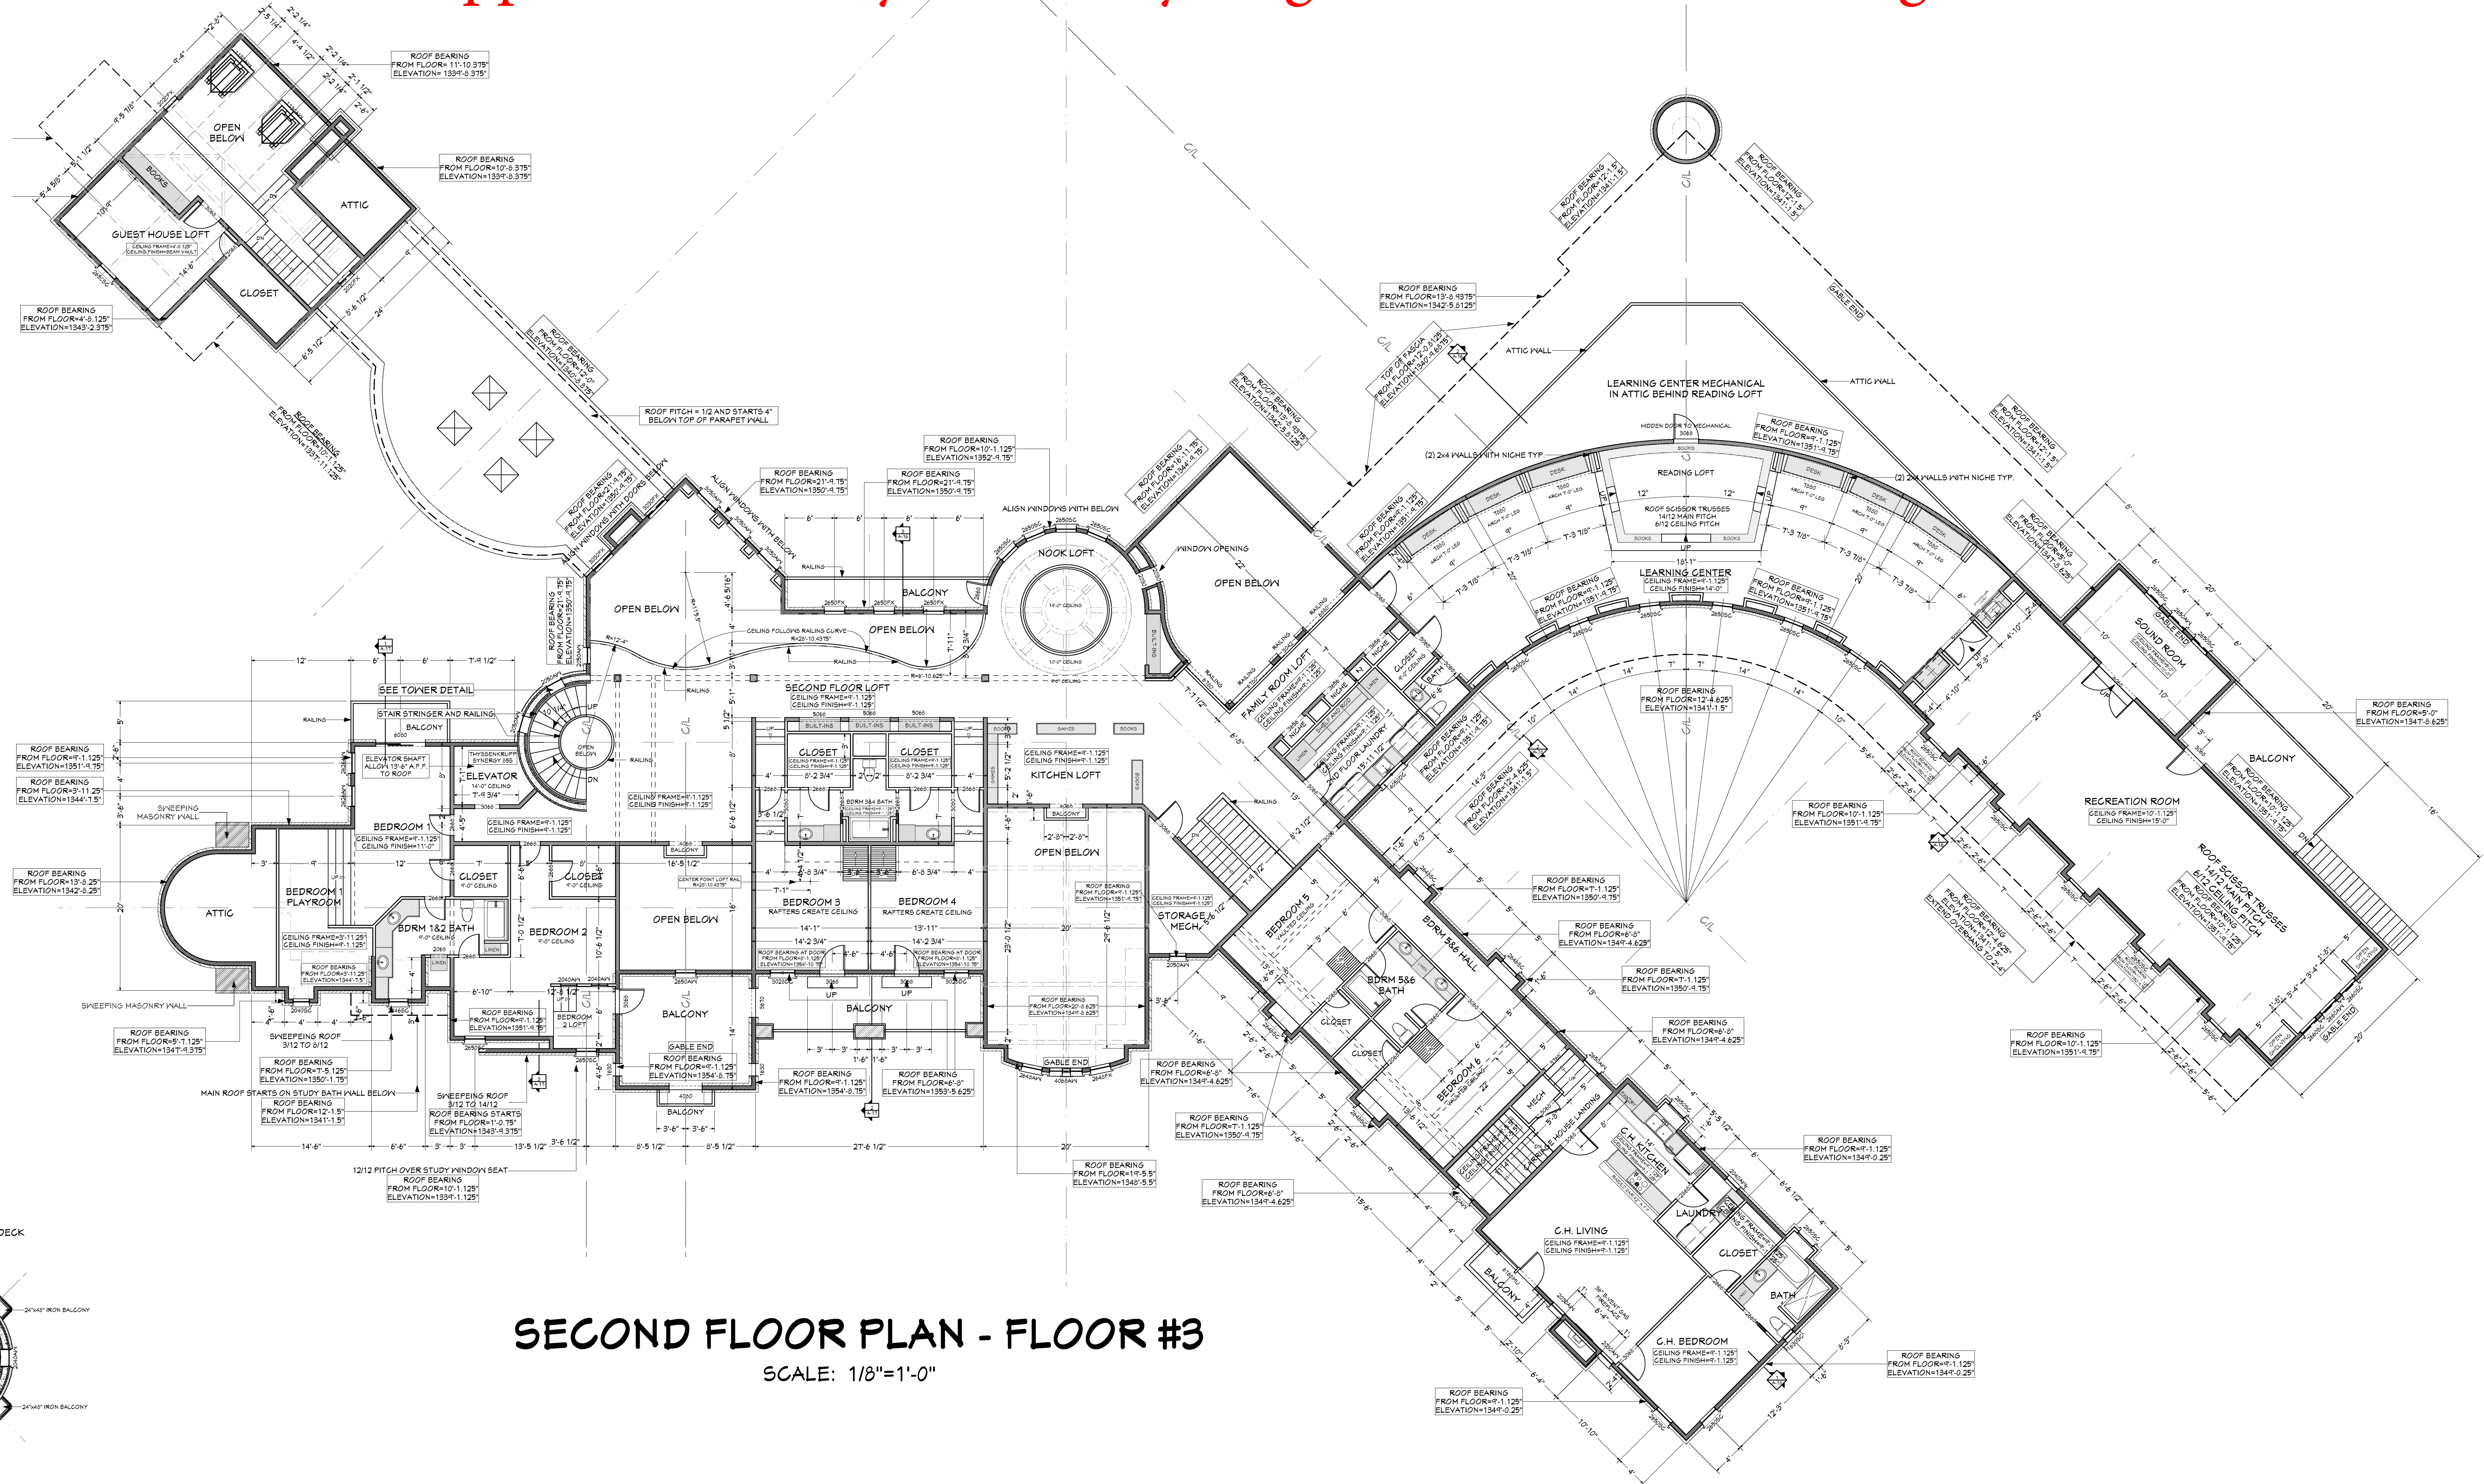


Lifestyle
HOMES
Builder's Choice

STICKS
STONES

Security Design Group
417.838.6443
www.securitydesigngroup.com

LEOPARD RIDGE
A PRIVATE RESIDENCE

HETHERINGTON
DESIGN & CONSULTING
417.838.6443 • @hetheringtondesign.com

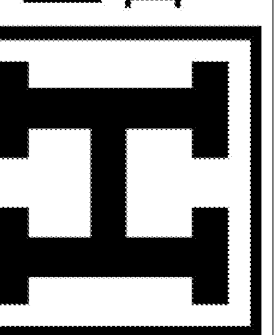

DATE
5/29/2012
SCALE
PER DRAWING
PAGE DESCRIPTION
SECOND FLOOR
THIRD FLOOR
TOWER PLANS
SHEET
A-6