

TRIPLE WIDE 8/12	HEADERS	SPAN	COLUMN STUDS
2-2X10 #2 SPF	106" (8'-10")	2-STUD	
2-1 1/2" X 9 1/2" LVL	148 1/4" (12'-4 1/4")	3-STUDS	
C9 X 13.4 CCHANNEL	228" (19'-0")	3-STUDS	

(THESE HEADERS ARE IN THE ROOF PERIMETER AND DO NOT DROP INTO THE MARRIAGE WALL)

EGRESS NOTE :

EGRESS WINDOWS MUST HAVE A MINIMUM NET CLEAR OPENING OF 5.7 SQ. FT. (5.0 SQ. FT. AT GRADE LEVEL). THE MINIMUM CLEAR WIDTH SHALL BE 20 INCHES, THE MINIMUM CLEAR HEIGHT SHALL BE 24 INCHES. THE SILL HEIGHT SHALL NOT EXCEED 44 INCHES ABOVE THE FLOOR. ALL MUST BE OPERABLE FROM THE INSIDE WITHOUT THE USE OF SEPERATE TOOLS.


FLAMESPREAD NOTE :

ALL WALL AND CEILING FINISHES MUST HAVE A FLAMESPREAD CLASSIFICATION OF LESS THAN 200. THE SMOKE DENSITY DEVELOPMENT RATING SHALL NOT BE GREATER THAN 450. ALL SMOKE DETECTORS ARE PROVIDED WITH A BATTERY BACKUP.

(S) = SHELF & ROD W/SHOE RACK UNDERNEATH	(1) = 1 SHELF	(2) = 2 SHELVES	(4) = 4 SHELVES	(5) = 5WEATER SHELVES
(+) = DUCT CONNECTOR	(6) = 20"x25"RAG/DOOR	(7) = 20"x25"RAG/WALL	(8) = 2"x10" OVER DOOR	(9) = 24X42 MIRROR
(10) = 4DX42 MIRROR	(11) = 58X42 MIRROR	(12) = 72X42 MIRROR	(13) = 22"x 30" ATIC ACCESS	(14) = STEREO
(15) = 28-0" WD-9/12-4	(16) = 38-0" WD-9/12-4	(17) = 28-0" WD-9/12-4	(18) = 12-1 1/2" 24'-3" DORMER	

FLOOR PLAN LEGEND

E	EGRESS WINDOW	T	THERMOSTAT
EP	ELECTRICAL PANEL	SD	SMOKE DETECTOR
PL	PRIVACY LOCK	SG	SAFETY GLAZED

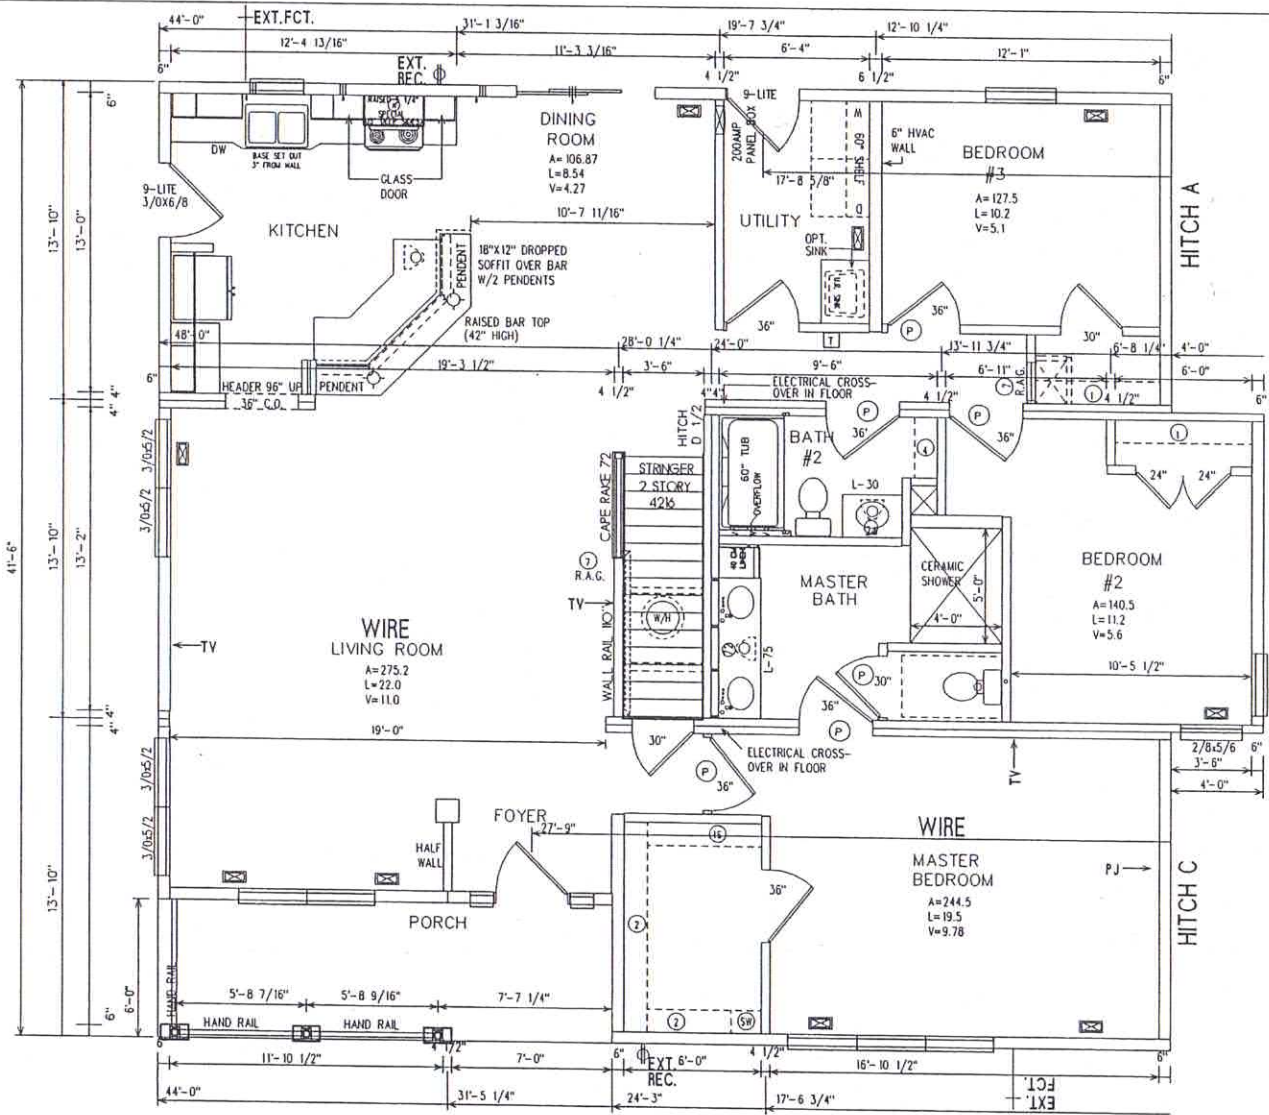

SERIAL # 5359
MODULAR

JOB NUMBER: 16094
DRAWING NUMBER:

DATE: 02/12/12
SCALE: 3/16"=1'-0"

DRY BY: RR
FILE NUMBER:

R-ANELL 810

TITLE: FLOOR PLAN-FIRST FLOOR
DESCRIPTION: PROJECT: 810

R-ANELL HOUSING GROUP, LLC
235 ANTHONY GROVE RD. CROUSE, N.C. 28033



100 MPH WIND ZONE

9'-0" FLAT THRU-OUT STD.